
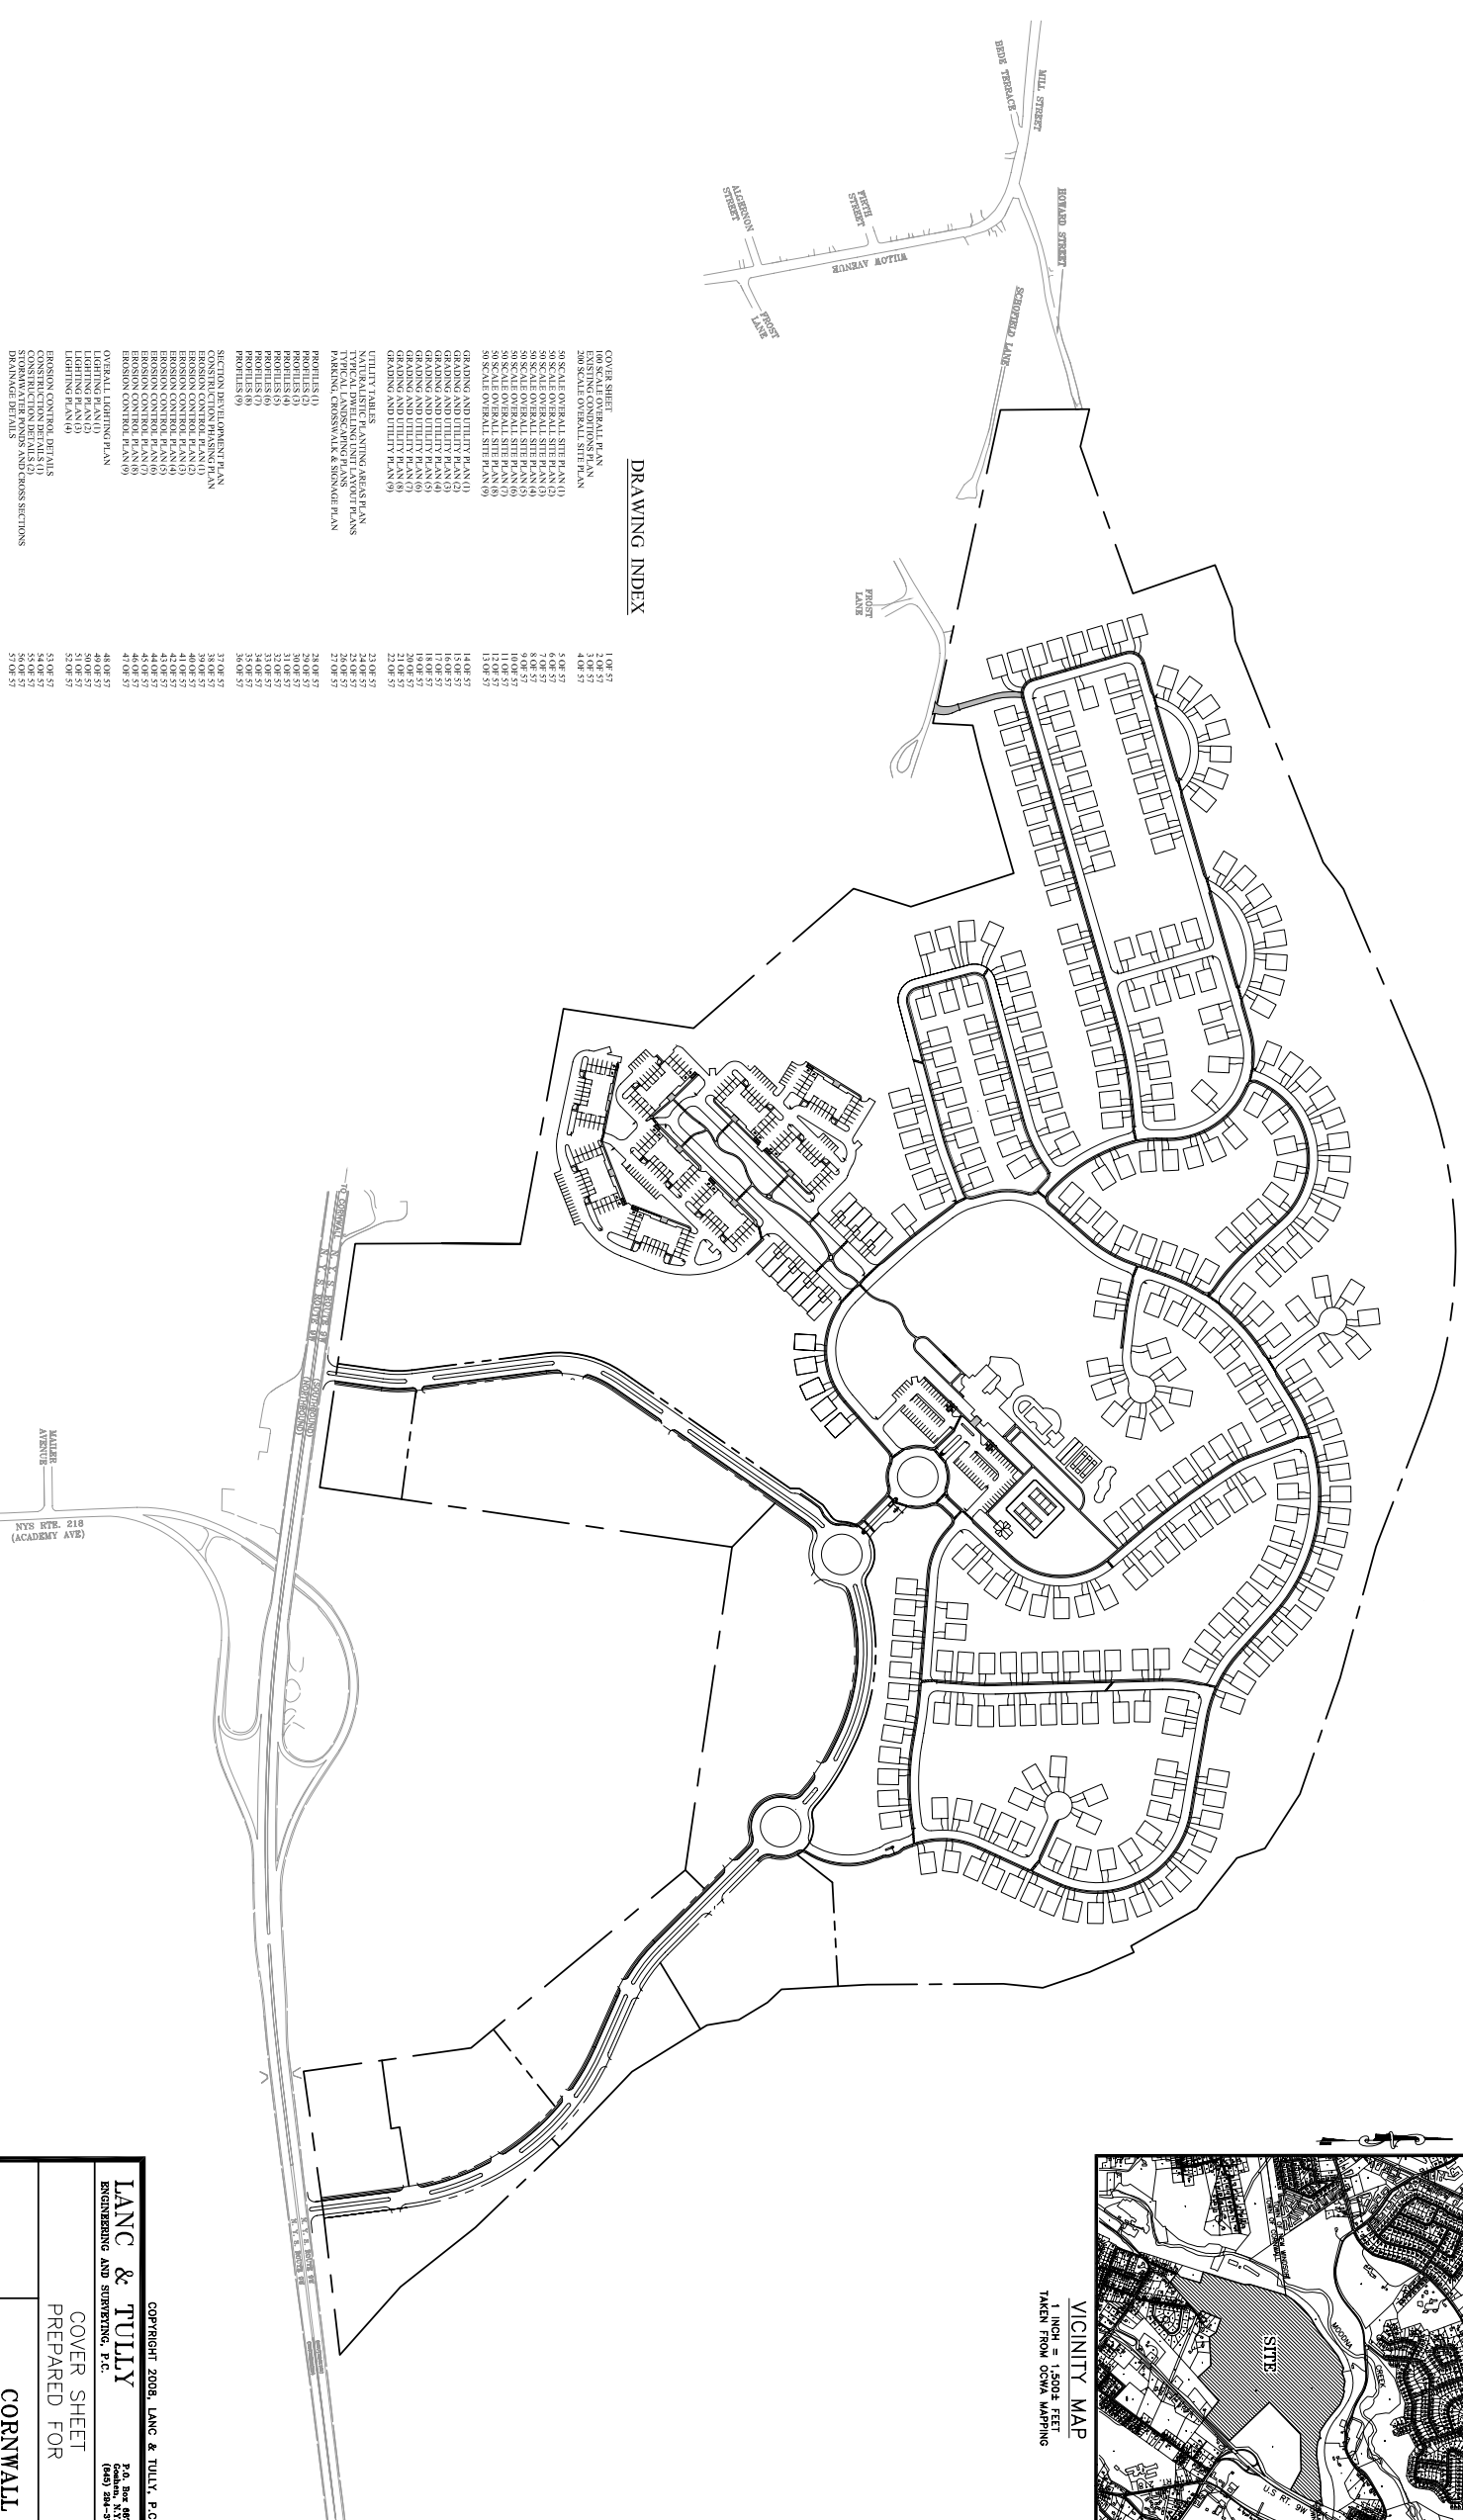


CORNWALL COMMONS LOT 10

TOWN OF CORNWALL

ORANGE COUNTY, NEW YORK

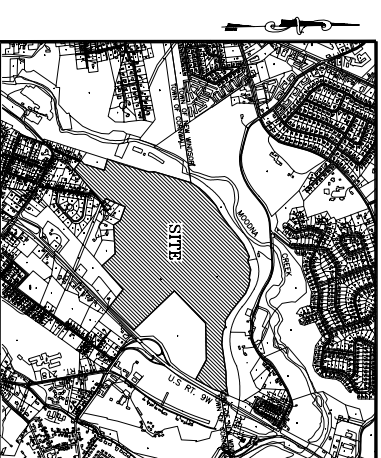

DRAWING INDEX

COVER SHEET (SCALE 1/8" = 1'-0")	1:08:57
EXISTING CONDITIONS PLAN	1:08:57
200 SCALE OVERALL SITE PLAN	4:08:57
50 SCALE OVERALL SITE PLAN (A)	5:08:57
50 SCALE OVERALL SITE PLAN (B)	7:08:57
50 SCALE OVERALL SITE PLAN (C)	8:08:57
50 SCALE OVERALL SITE PLAN (D)	9:08:57
50 SCALE OVERALL SITE PLAN (E)	10:08:57
50 SCALE OVERALL SITE PLAN (F)	11:08:57
50 SCALE OVERALL SITE PLAN (G)	12:08:57
50 SCALE OVERALL SITE PLAN (H)	13:08:57
50 SCALE OVERALL SITE PLAN (I)	14:08:57
GRADING AND UTILITY PLAN (A)	15:08:57
GRADING AND UTILITY PLAN (B)	16:08:57
GRADING AND UTILITY PLAN (C)	17:08:57
GRADING AND UTILITY PLAN (D)	18:08:57
GRADING AND UTILITY PLAN (E)	19:08:57
GRADING AND UTILITY PLAN (F)	20:08:57
GRADING AND UTILITY PLAN (G)	21:08:57
GRADING AND UTILITY PLAN (H)	22:08:57
GRADING AND UTILITY PLAN (I)	23:08:57
NATURALISTIC PLANTING AREAS PLANS	24:08:57
TYPICAL LANDSCAPING PLANS	25:08:57
PARKING, CROSSWALK & SIGNAGE PLAN	26:08:57
PROFILES (A)	27:08:57
PROFILES (B)	28:08:57
PROFILES (C)	29:08:57
PROFILES (D)	30:08:57
PROFILES (E)	31:08:57
PROFILES (F)	32:08:57
PROFILES (G)	33:08:57
PROFILES (H)	34:08:57
PROFILES (I)	35:08:57
SECTION DEVELOPMENT PLAN	36:08:57
CONSTRUCTION PHASING PLAN	37:08:57
EMISION CONTROL PLAN (A)	38:08:57
EMISION CONTROL PLAN (B)	39:08:57
EMISION CONTROL PLAN (C)	40:08:57
EMISION CONTROL PLAN (D)	41:08:57
EMISION CONTROL PLAN (E)	42:08:57
EMISION CONTROL PLAN (F)	43:08:57
EMISION CONTROL PLAN (G)	44:08:57
EMISION CONTROL PLAN (H)	45:08:57
EMISION CONTROL PLAN (I)	46:08:57
OVERALL LIGHTING PLAN	47:08:57
LIGHTING PLAN (A)	48:08:57
LIGHTING PLAN (B)	49:08:57
LIGHTING PLAN (C)	50:08:57
EMISION CONTROL DETAILS	51:08:57
CONSTRUCTION DETAILS	52:08:57
LANDSCAPING DETAILS	53:08:57
PARKING DETAILS	54:08:57
SECTION DETAILS	55:08:57
EMISION CONTROL DETAILS	56:08:57
CONSTRUCTION DETAILS	57:08:57
LANDSCAPING DETAILS	58:08:57
PARKING DETAILS	59:08:57
SECTION DETAILS	60:08:57

COPYRIGHT 2008, LANCG & TULLY, P.C.

LANCG & TULLY
ENGINEERING AND SURVEYING, P.C.
P.O. Box 487, Rt. 287
Cornwall, NY 12424
(845) 338-5700

COVER SHEET
PREPARED FOR
CORNWALL COMMONS LOT 10
TOWN OF CORNWALL
ORANGE COUNTY, NEW YORK

Drawn By:	Checked By:	Date:	Scale:	Sheet No.:	Total No. of Sheets:
WMS	WMS	1/1/2008	1" = 200'	10 of 10	10 of 10

DATE: MARCH 26, 2007
 DATE: APRIL 14, 2007
 DATE: MAY 27, 2007
 DATE: JUNE 26, 2008
 DATE: JULY 25, 2008
 DATE: AUGUST 22, 2008
 DATE: SEPTEMBER 15, 2008
 DATE: OCTOBER 24, 2008
 DATE: NOVEMBER 24, 2008

SCALE: 1" = 200'

DATE: MARCH 26, 2007