
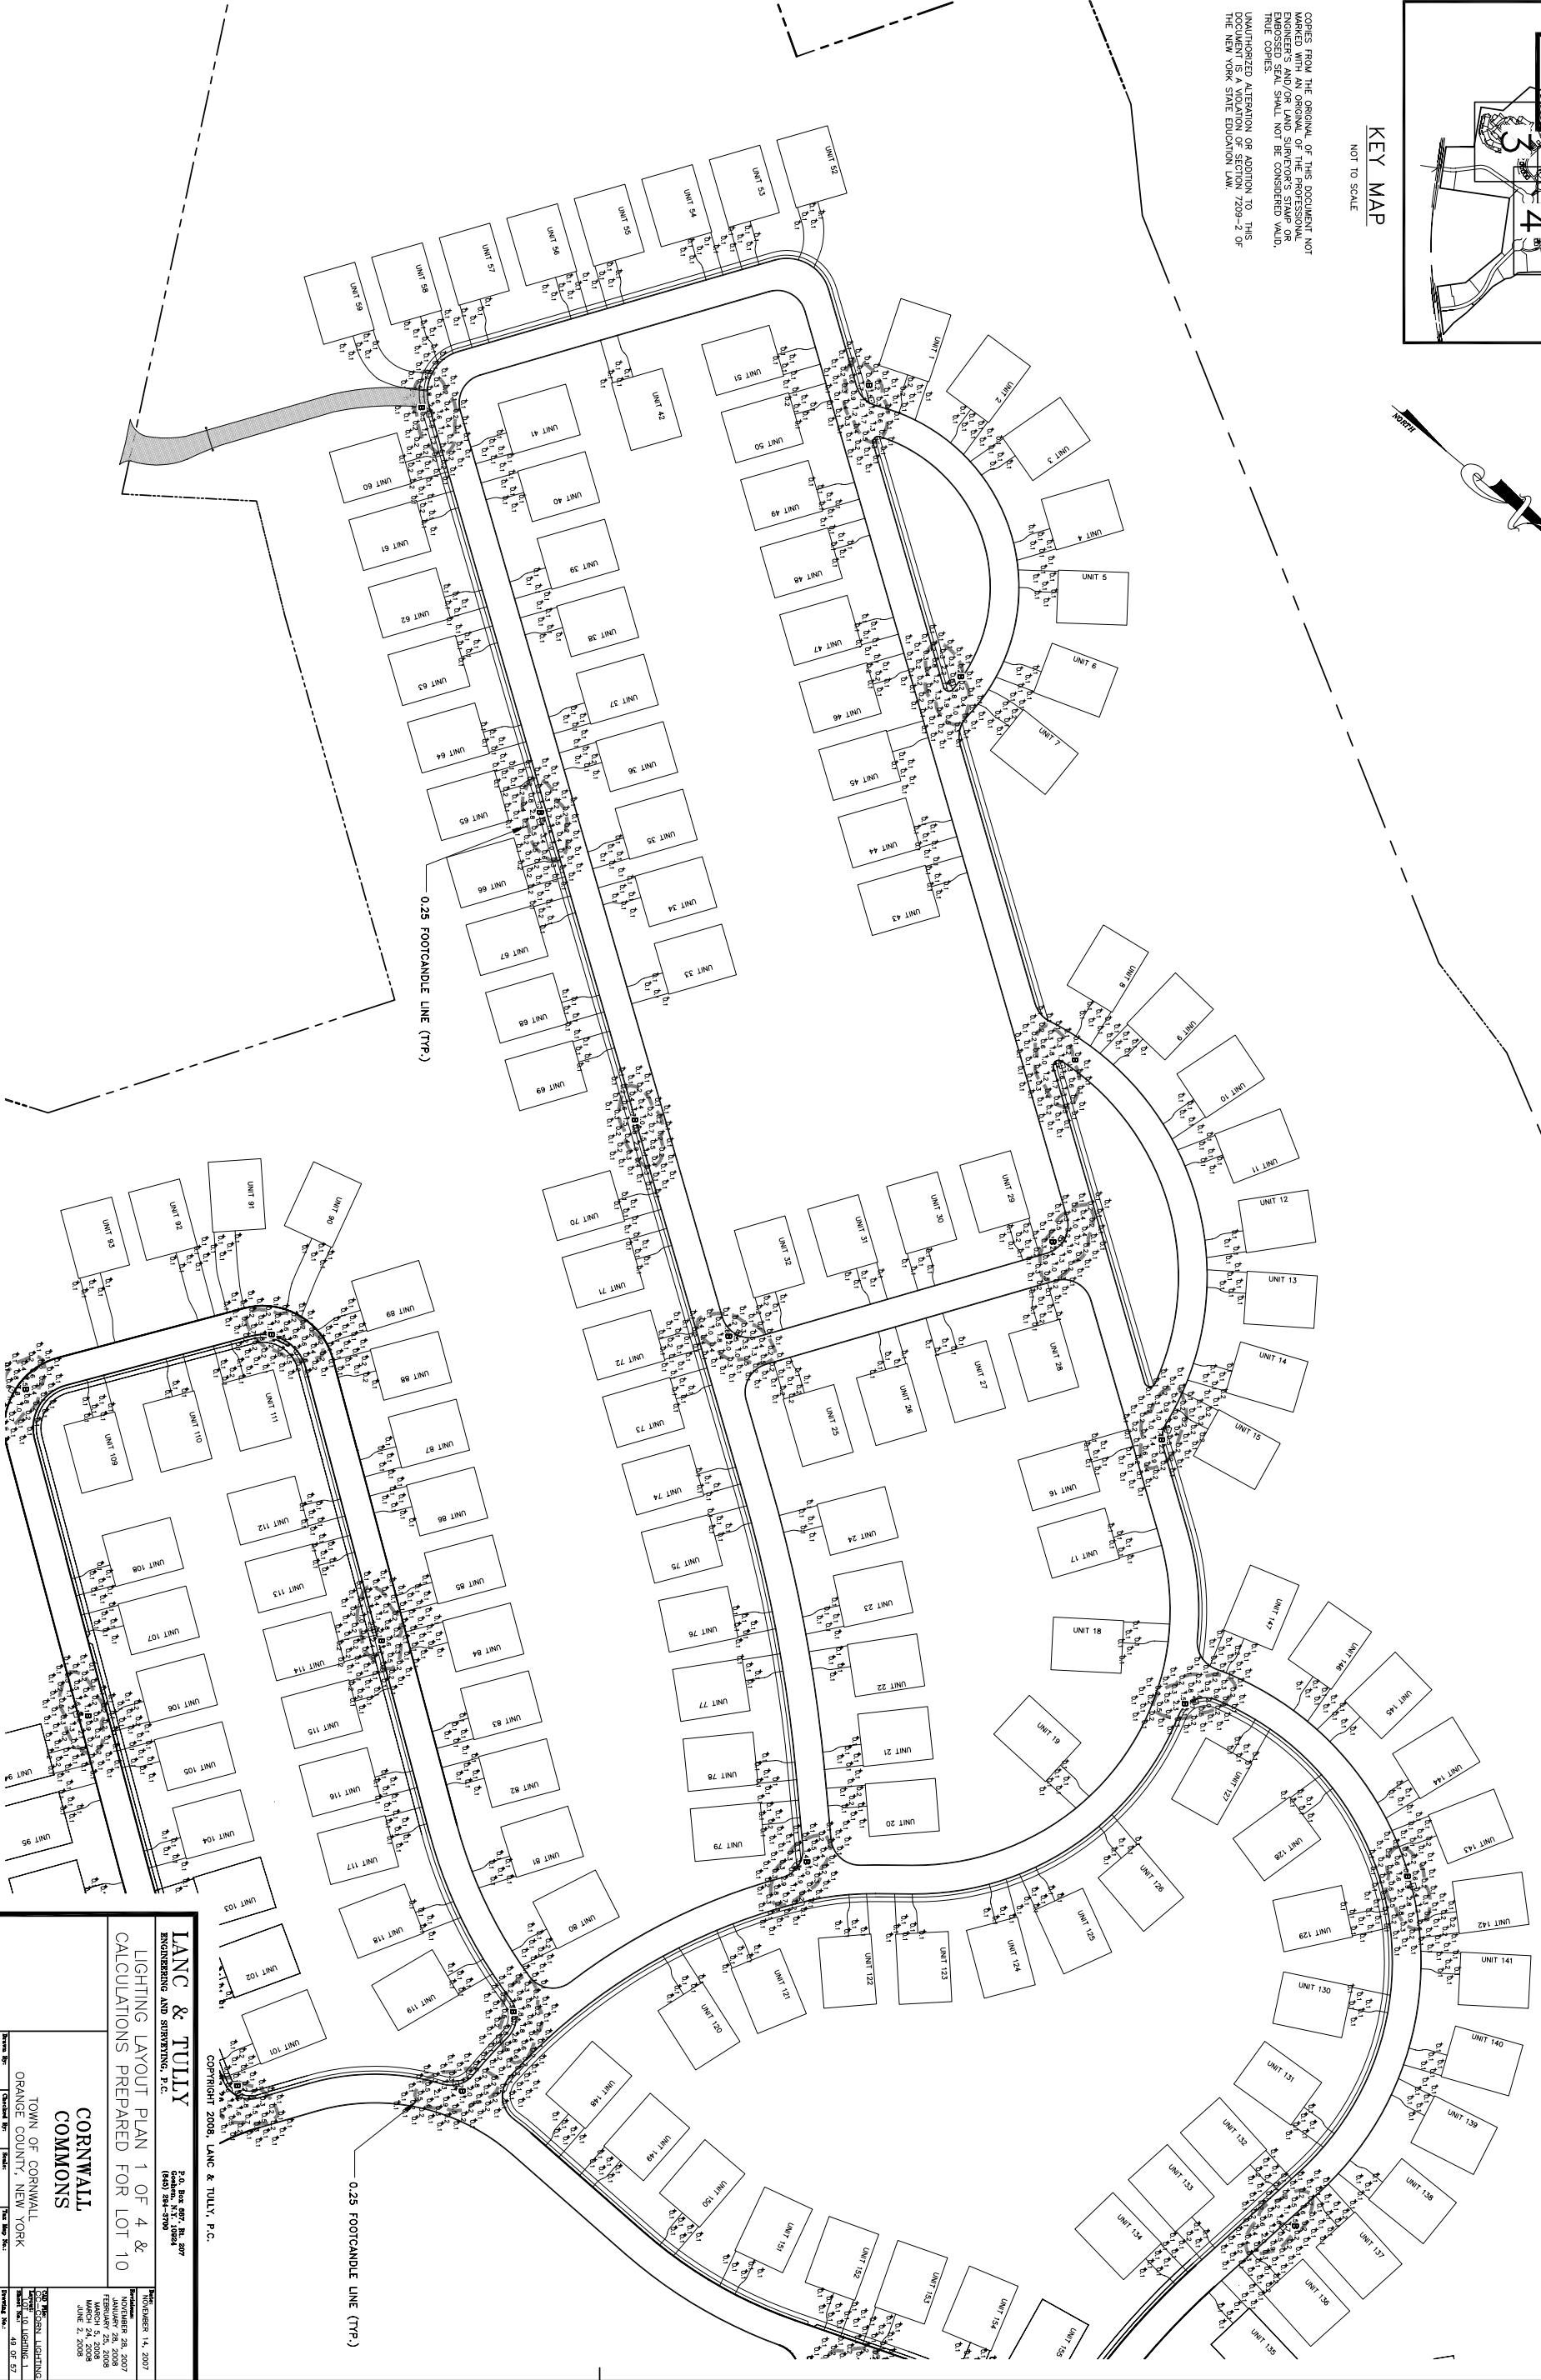
 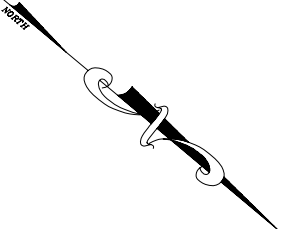


KEY MAP
NOT TO SCALE

COPIES FROM THE ORIGINAL OF THIS DOCUMENT NOT BEING REPRODUCED FOR ANY PURPOSES WITHOUT THE WRITTEN PERMISSION OF THE ENGINEER'S AND/OR LAND SURVEYOR'S STAMP OR EMBOSSED SEAL SHALL NOT BE CONSIDERED VALID. TRADE COPIES. UNAUTHORIZED ALTERATION OR ADDITION TO THIS DOCUMENT IS A VIOLATION OF SECTION 7209-2 OF THE NEW YORK STATE EDUCATION LAW.



LANC & TULLY
ENGINEERING AND SURVEYING, P.C.
P.O. Box 487 Rt. 207
Goshen, N.Y. 10924
(845) 248-2100

TOWN OF CORNWALL
ORANGE COUNTY, NEW YORK

CORNWALL COMMONS

LIGHTING LAYOUT PLAN 1 OF 4 & CALCULATIONS PREPARED FOR LOT 10

NOVEMBER 14, 2007
REVISIONS: 24, 2007
JANUARY 28, 2008
FEBRUARY 25, 2008
MARCH 24, 2008
JUNE 2, 2008

DATE: 11/14/07
PROJECT: 07-00000000-1
SHEET NO.: 53 OF 57
DRAWING NO.: 148 - 301